



BATTERY ON TONGUE - OPERATES COMPRESSOR, FAN, PLUS DUPLICATE LIGHTS. WIRE THRU SEPARATE RACEWAYS - APART FROM 110V SYSTEM.

GROUND TO COACH POWER SUPPLY CABLE #25 W/STAINLESS STEEL CABLE #10-3 AWG TYPE ST WIRE (W/POLARIZED CAP) 30A-250V

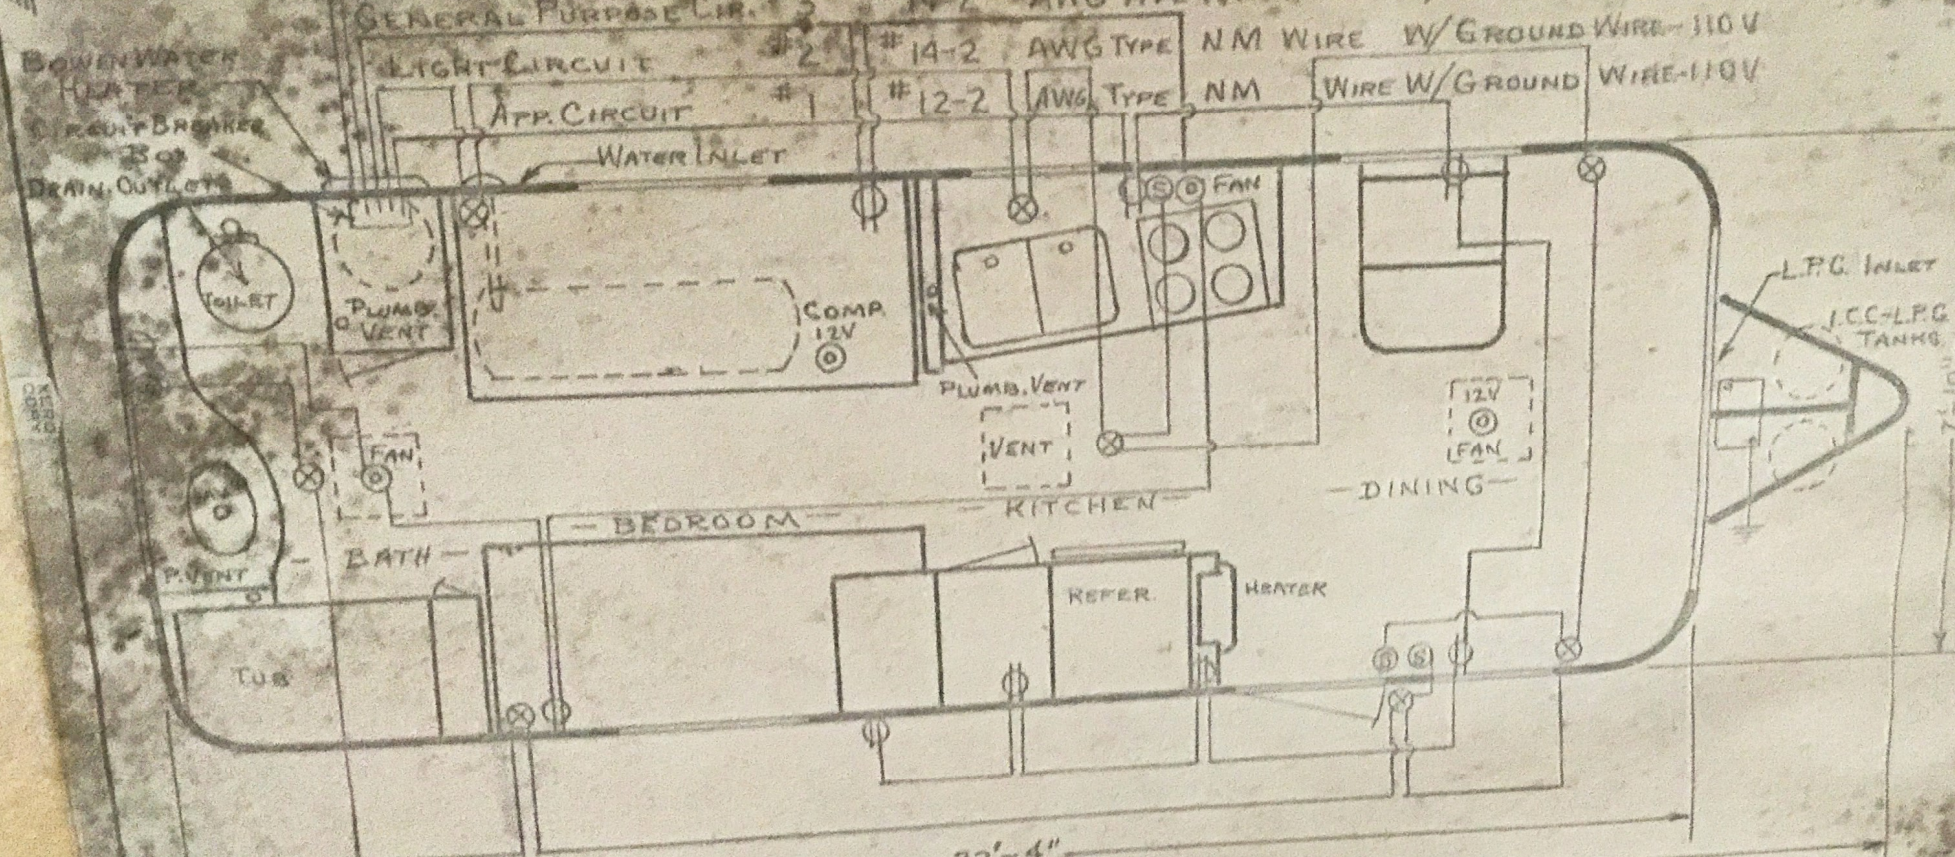

07 01 26 26

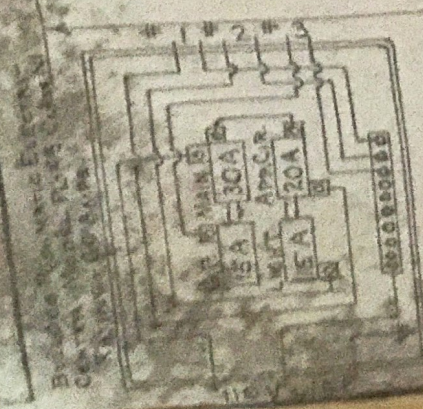

ELECTRICAL LOAD	
LIGHTING - 22' x 7.5' = 165 ^{sq} ft	
165 ^{sq} ft x 3 WATTS PER ^{sq} ft =	495W
1 APPLIANCE CIRCUIT =	1500W
TOTAL WATTS	1995W
1995W ÷ 120V =	16.6A
3 FANS @ .6A =	1.8A
MAT. AMP. LOAD	17.8A
ELECT. TEST EQUIP. USED - IDEAL	
BLOOD WATER BATES 200V TO 250V	

⊙ = MOTOR ⊗ = LIGHT ⊕ = CO ⊕ = SWITCH

SILVER STREAK TRAILER CO.
2319 No. CHICO AVE.; EL MONTE, CALIF.
SCALE 3/8" = 1'
DATE 7-20-64

FLOOR PLAN & ELECTRICAL SYSTEM
WIDTH 7'-10"
LENGTH 26'-0"
DRAWING NUMBER MODEL 5.5RT

DRAWN BY KEN
REVISED 9-16-65

DRAWING NUMBER MODEL 5.5RT